

NOTES: Portables P5, P6 and P20

See Scope of Work Summaries for additional information.

Refer to A1.00 and A1.01: Portables P5, P6 and P20 to be relocated in this project. This work is in addition to the relocation of the Interim Portables:

CAT 30:

1. Refer to partial Grading Plan this sheet for location and elevations.
2. Provide AC ramps per Detail 20 this sheet.
3. Provide handrails per partial Grading Plan and Detail 19 this sheet.
4. Provide sewer and water connections to P20 per partial Civil Plan and notes this sheet. Refer to C3.01 and Scope of work Plan Sheet SW-02 to coordinate sewer and water installation with restroom portable.
5. Provide drywells for HVAC condensate at P5, P6 and P20. Refer to Sheet P2.01 and Detail 1/P7.00



Cat 19:

1. Provide electrical connections per "E" sheets. Buildings will be fed from Distribution Board DBB via common trench with P19 and P20. Refer to Sheet E1.01.
2. Provide Fire Alarm Connections: P20, P5 & P6 shall be connected to the Fire Alarm system via underground conduit to the Relocated Portable Restroom. Provide P20, P5 and P6 with a temporary manual system including new pull stations, horns and strobes. Fire Alarm system in these portables to be upgraded by others in a future phase.
3. Provide connection to Technology systems from existing Portable P14 to P6 as shown on partial Technology Plan this sheet. See T1.01 for continuation to connect interim portables to Portable P6.

SUMMER 2019 SCOPE of WORK

Portables P5, P6, P20

Madison ES Interim Housing

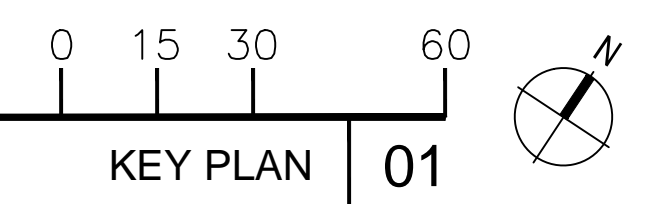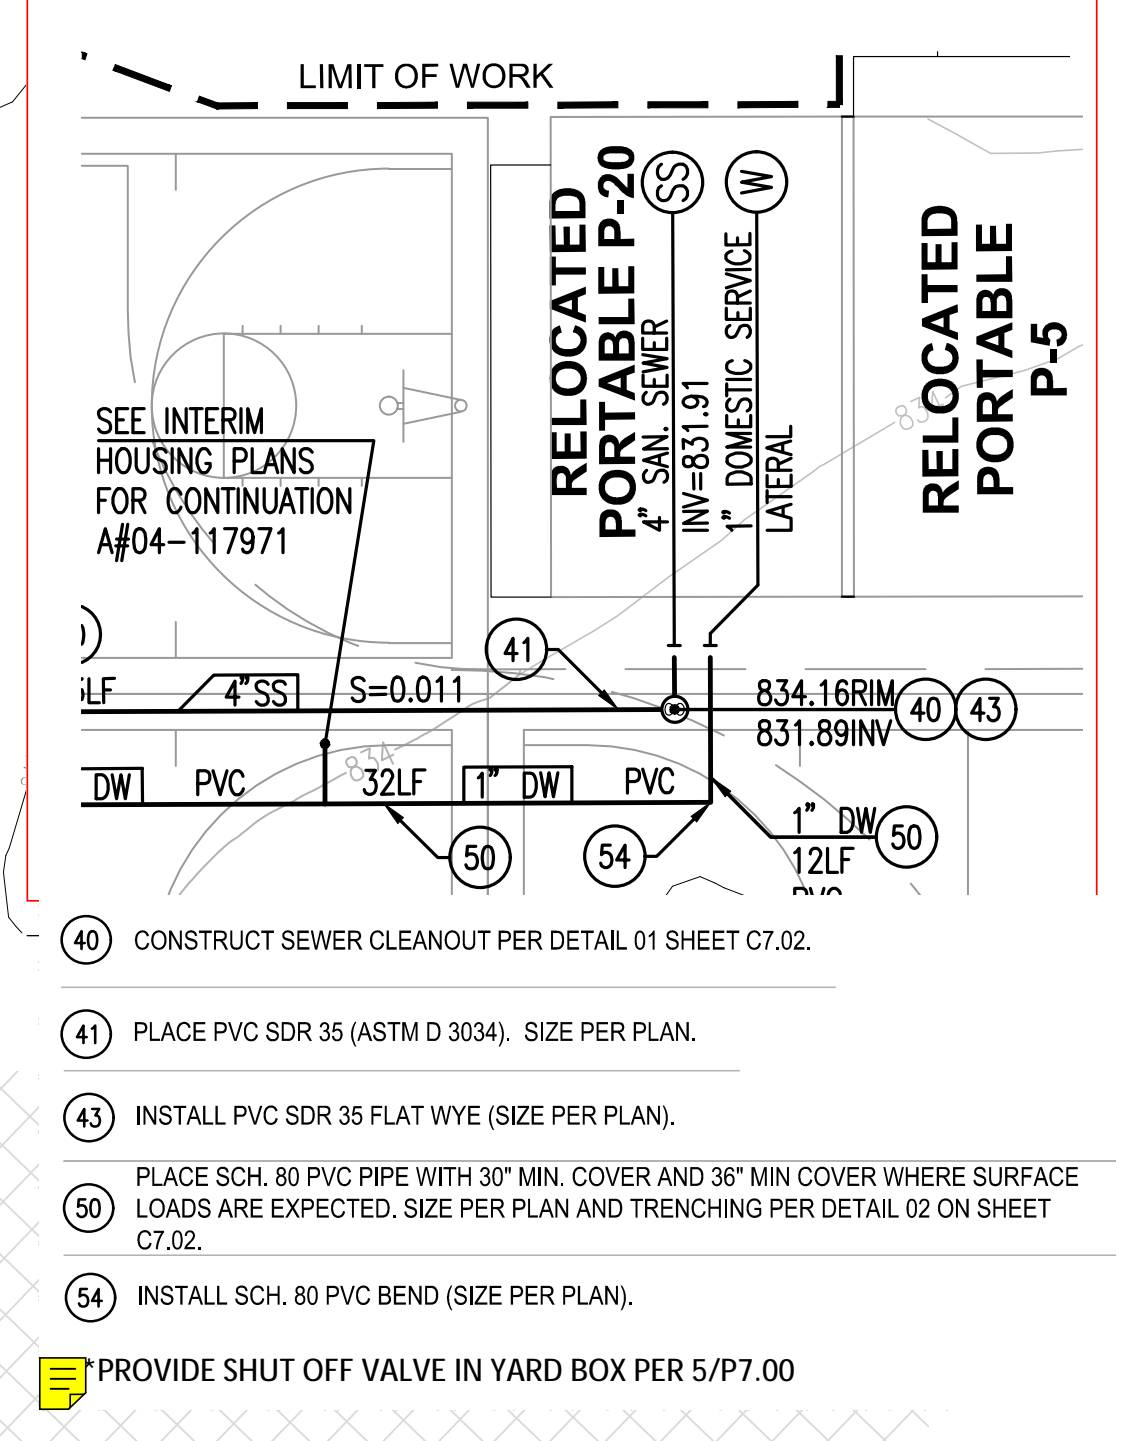

MADISON ELEMENTARY SCHOOL
 3635 Madison Street, Riverside CA 92504
 Developed for
 Riverside Unified School District

Revision	Date



Job No. 17205.10
 Date 10/12/2018
 Checked by LR
 Scale 1" = 30'-0"

Scope of Work
 Plan Draft